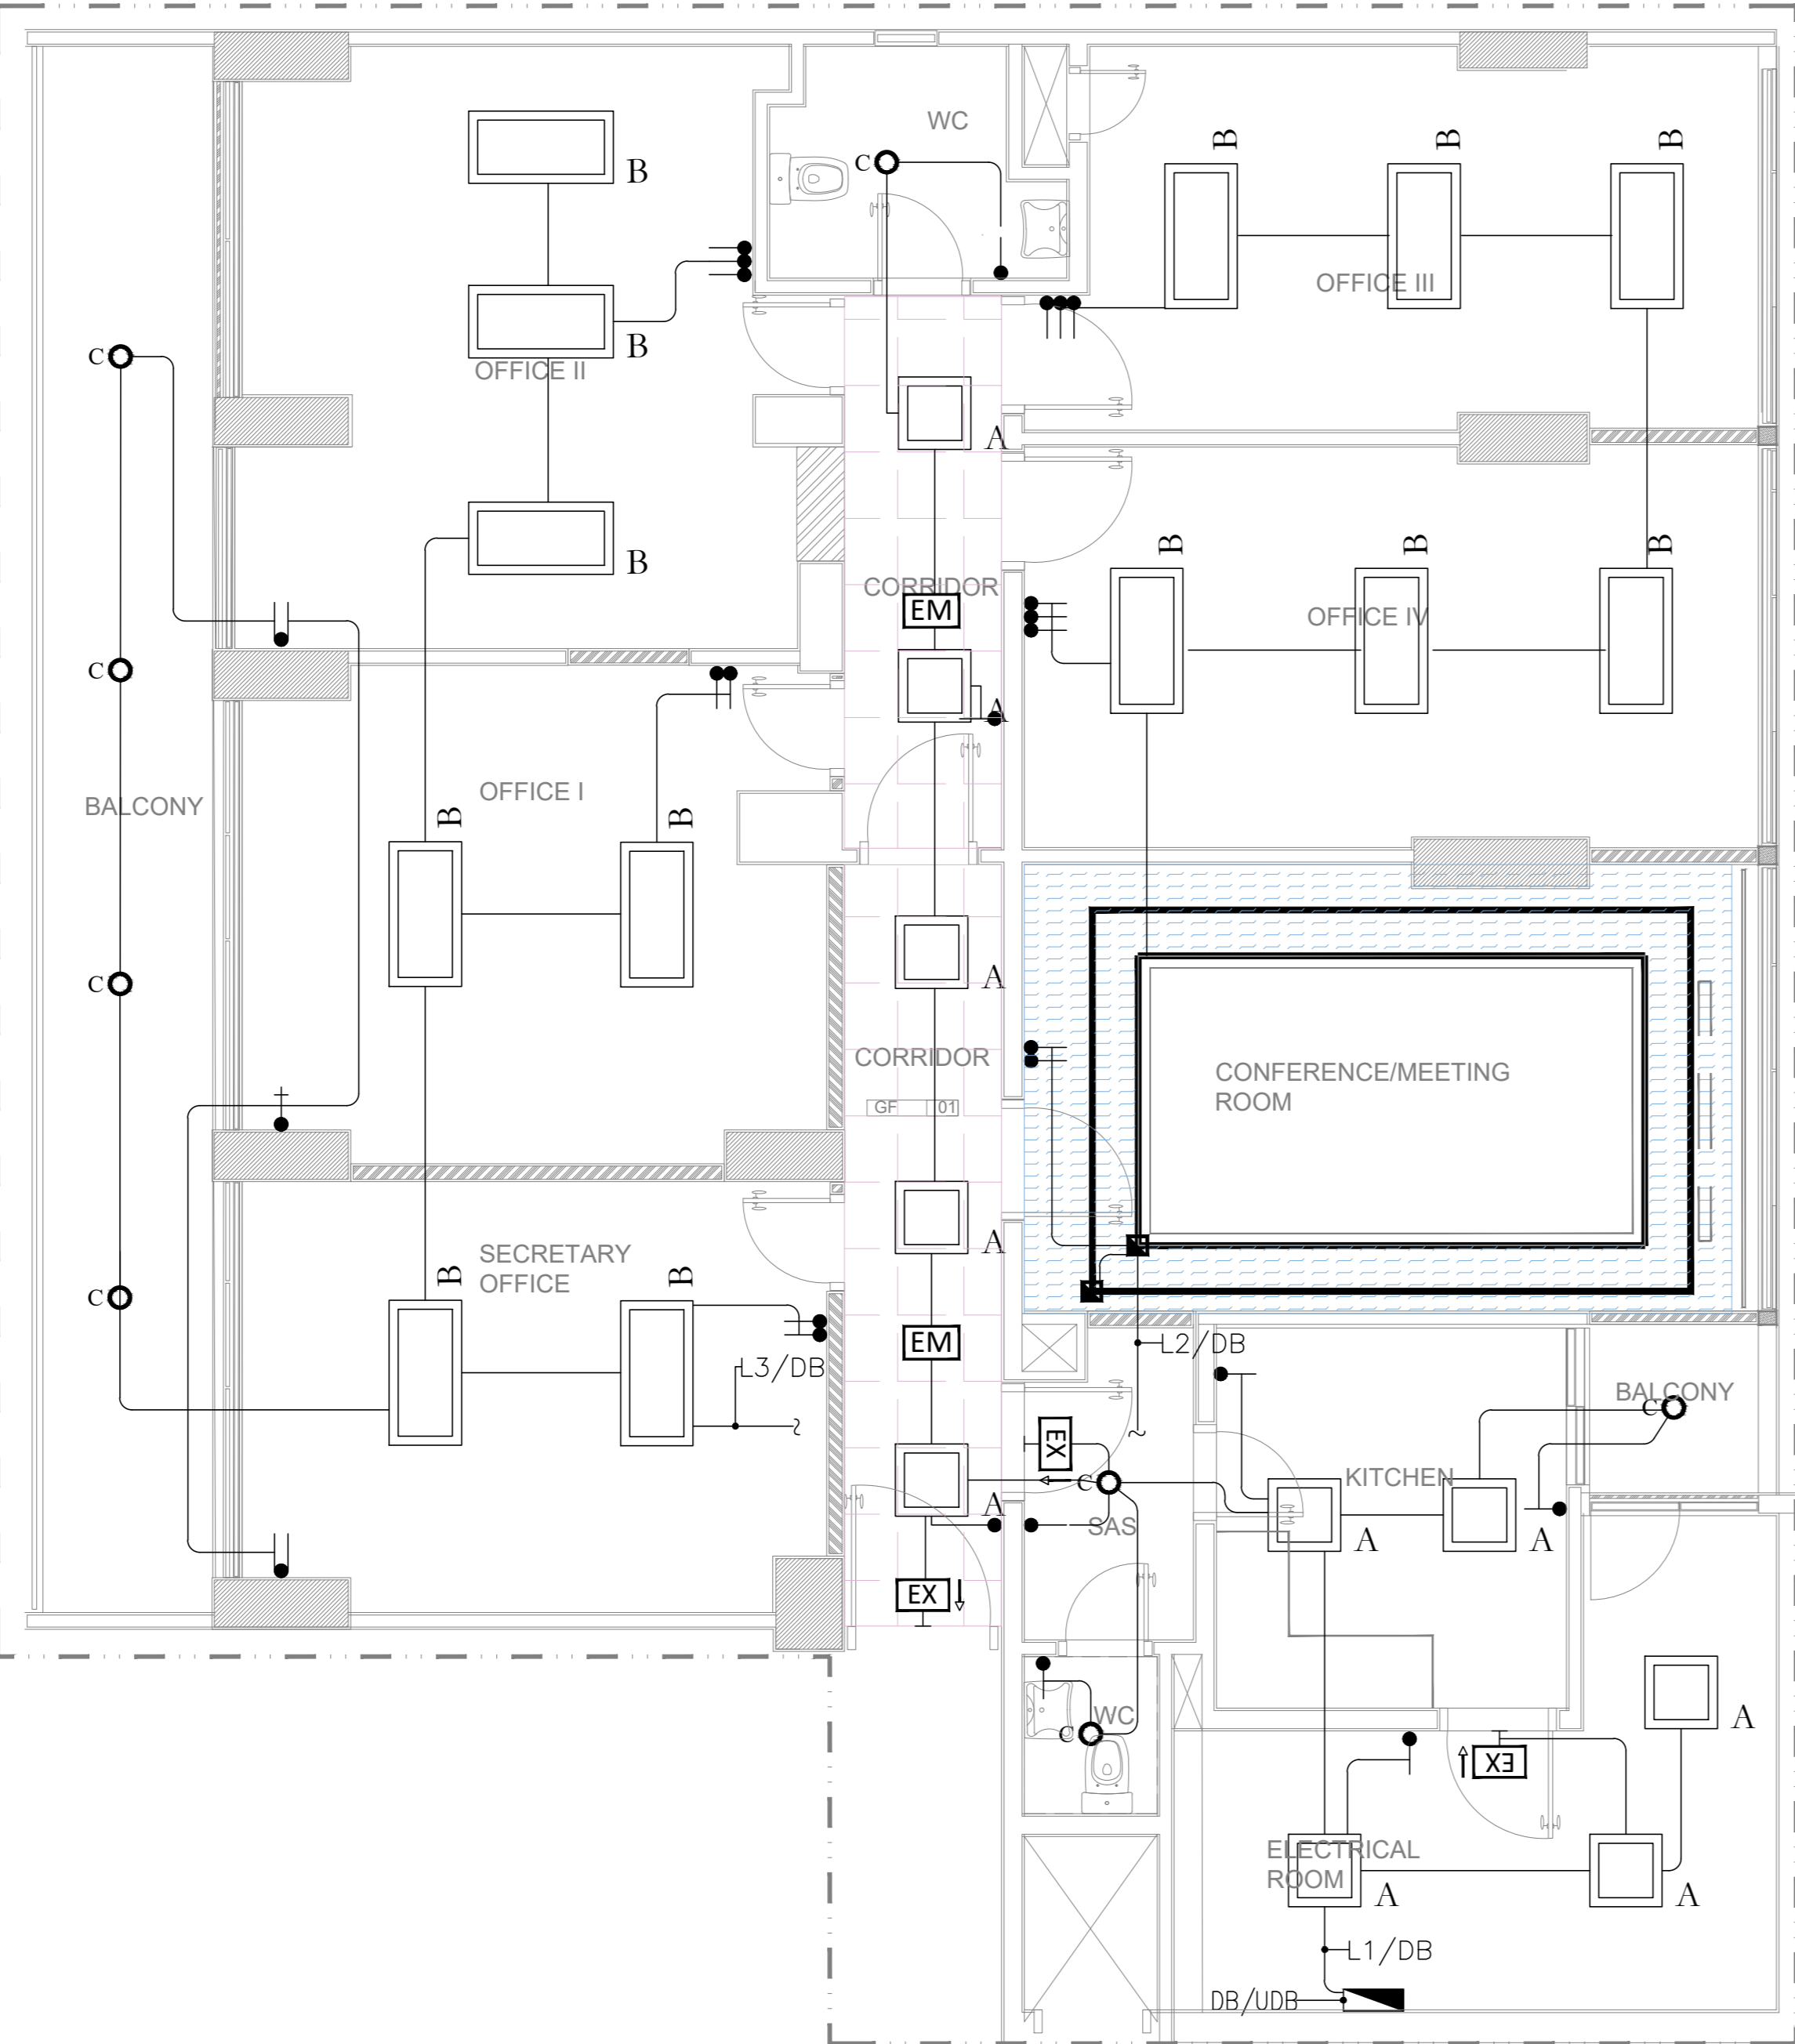




 
 
 
 

 


LIGHTING LAYOUT



ELECTRICAL LEGENDS

LIGHTING SYSTEM LEGEND	
SYMBOLS	DESCRIPTION
 A	RECESSED 60X60 LED PANEL PROTECTION RATING: IP22 40W LED LAMP – 4000K.
 B	RECESSED 60X120 LED PANEL PROTECTION RATING: IP22 80W LED LAMP – 4000K.
 C	RECESSED CEILING LINEAR LED LIGHT PROFILE. 20W LED PER LAMP – 4000K.
 O	RECESSED CEILING MOUNTED ROUND LIGHTING FIXTURE. DIAM:20CM PROTECTION RATING: IP22 18W LED LAMP – 4000K.
 P	CEILING SUSPENDED SPOTLIGHT, DIRECTIONAL PROTECTION RATING: IP22 11W LED LAMP – 4000K.
 EM	INDIRECT LIGHTING STRIP LED 15W PER LM – 4000K.
 EX	SELF CONTAINED WALL/CEILING MOUNTED EXIT LIGHT, POLYCARBONATE BODY, COVER WITH SILK SCREEN LEGEND,5W LED LAMP, 3h DURATION OF EMERGENCY LIGHTING BATTERY, IP54
 1	10A 250V ONE WAY ONE GANG SWITCH
 2	10A 250V TWO WAY ONE GANG SWITCH
 3	10A 250V INTERMEDIATE ONE GANG SWITCH

Key Plan




REV	BY	APP	DESCRIPTION	DATE

Revisions

NOTES:

1. THIS DRAWING IS COPYRIGHTED AND IS NOT TO BE USED FOR ANY PURPOSE OTHER THEN FOR WHICH IT IS SUPPLIED.
2. ALL DIMENSIONS ARE IN CENTIMETERS UNLESS OTHERWISE INDICATED. ALL LEVELS ARE IN METERS UNLESS OTHERWISE INDICATED.
3. ALL WORKS SHALL BE CARRIED OUT IN ACCORDANCE WITH CURRENT SERVICES SEPARATIONS AND STANDARD DETAILS. THE CONTRACTORS SHALL COMPLY WITH ALL UTILITIES REQUIREMENTS AND PROVIDE ALL NECESSARY NOTICE AND ATTENDANCE TO THE CONCERNED AUTHORITIES PRIOR TO COMMENCEMENT OF ANY WORK ON THE SITE.
4. THE DRAWINGS SHOULD BE READ IN CONJUNCTION WITH OTHER RELEVANT ARCHITECTURAL, STRUCTURAL, MECHANICAL, ELECTRICAL AND CIVIL DRAWINGS AND ALL RELEVANT SECTIONS OF THE SPECIFICATIONS.
5. BEFORE STARTING ANY WORK, THE CONTRACTOR HAS TO SUBMIT SHOP DRAWINGS SHOWING ALL DETAILS NEEDED. THE ENGINEER APPROVAL OF THE SHOP DRAWING MUST BE OBTAINED PRIOR TO COMMENCEMENT OF WORK.
6. DO NOT SCALE DRAWINGS, USE FIGURED DIMENSIONS ONLY.
7. REPORT ANY DISCREPANCIES IMMEDIATELY TO THE ENGINEER.

THIS DRAWING IS A COPYRIGHT. DO NOT SCALE FROM THE DRAWING. THE CONTRACTOR AND HIS SUB-CONTRACTORS ARE TO VERIFY ALL DIMENSIONS ON SITE BEFORE MAKING SHOP DRAWINGS OR COMMENCING MANUFACTURE.



AGENCE FRANCAISE D'EXPERTISE  
TECHNIQUE INTERNATIONALE  
MHM Center- Peres Street - Adliye Beirut, Lebanon

PROGRAMME - PROJECT NAME:  
Supporting progress in key areas of public administration reform in Lebanon.

CONSULTANT:  
ARCHITECT MANALE BASSIL  
JBEIL, Lebanon

PROJECT:  
PUBLIC PROCUREMENT AUTHORITY (PPA)

PLOT NO.:	BLOCK:
-	-

Sheet Information

PROJECT NBR.	-
PROJECT PHASE	TENDER
DISCIPLINE	ARCHITECTURAL
SECTOR	-
BUILDING	-
DESIGNED	MB
DRAWN	MB
CHECKED	-
APPROVED	-
DATE	15.05.2026
SCALE	1/50
SHEET SIZE	A0

Sheet Title

GROUND FLOOR PLAN LAYOUT  
LIGHTING LAYOUT

Sheet nbr.

T - EL - 102 - R00

Phase	Discipline	Floor Area	Drawing Number	Revision
-------	------------	------------	----------------	----------